


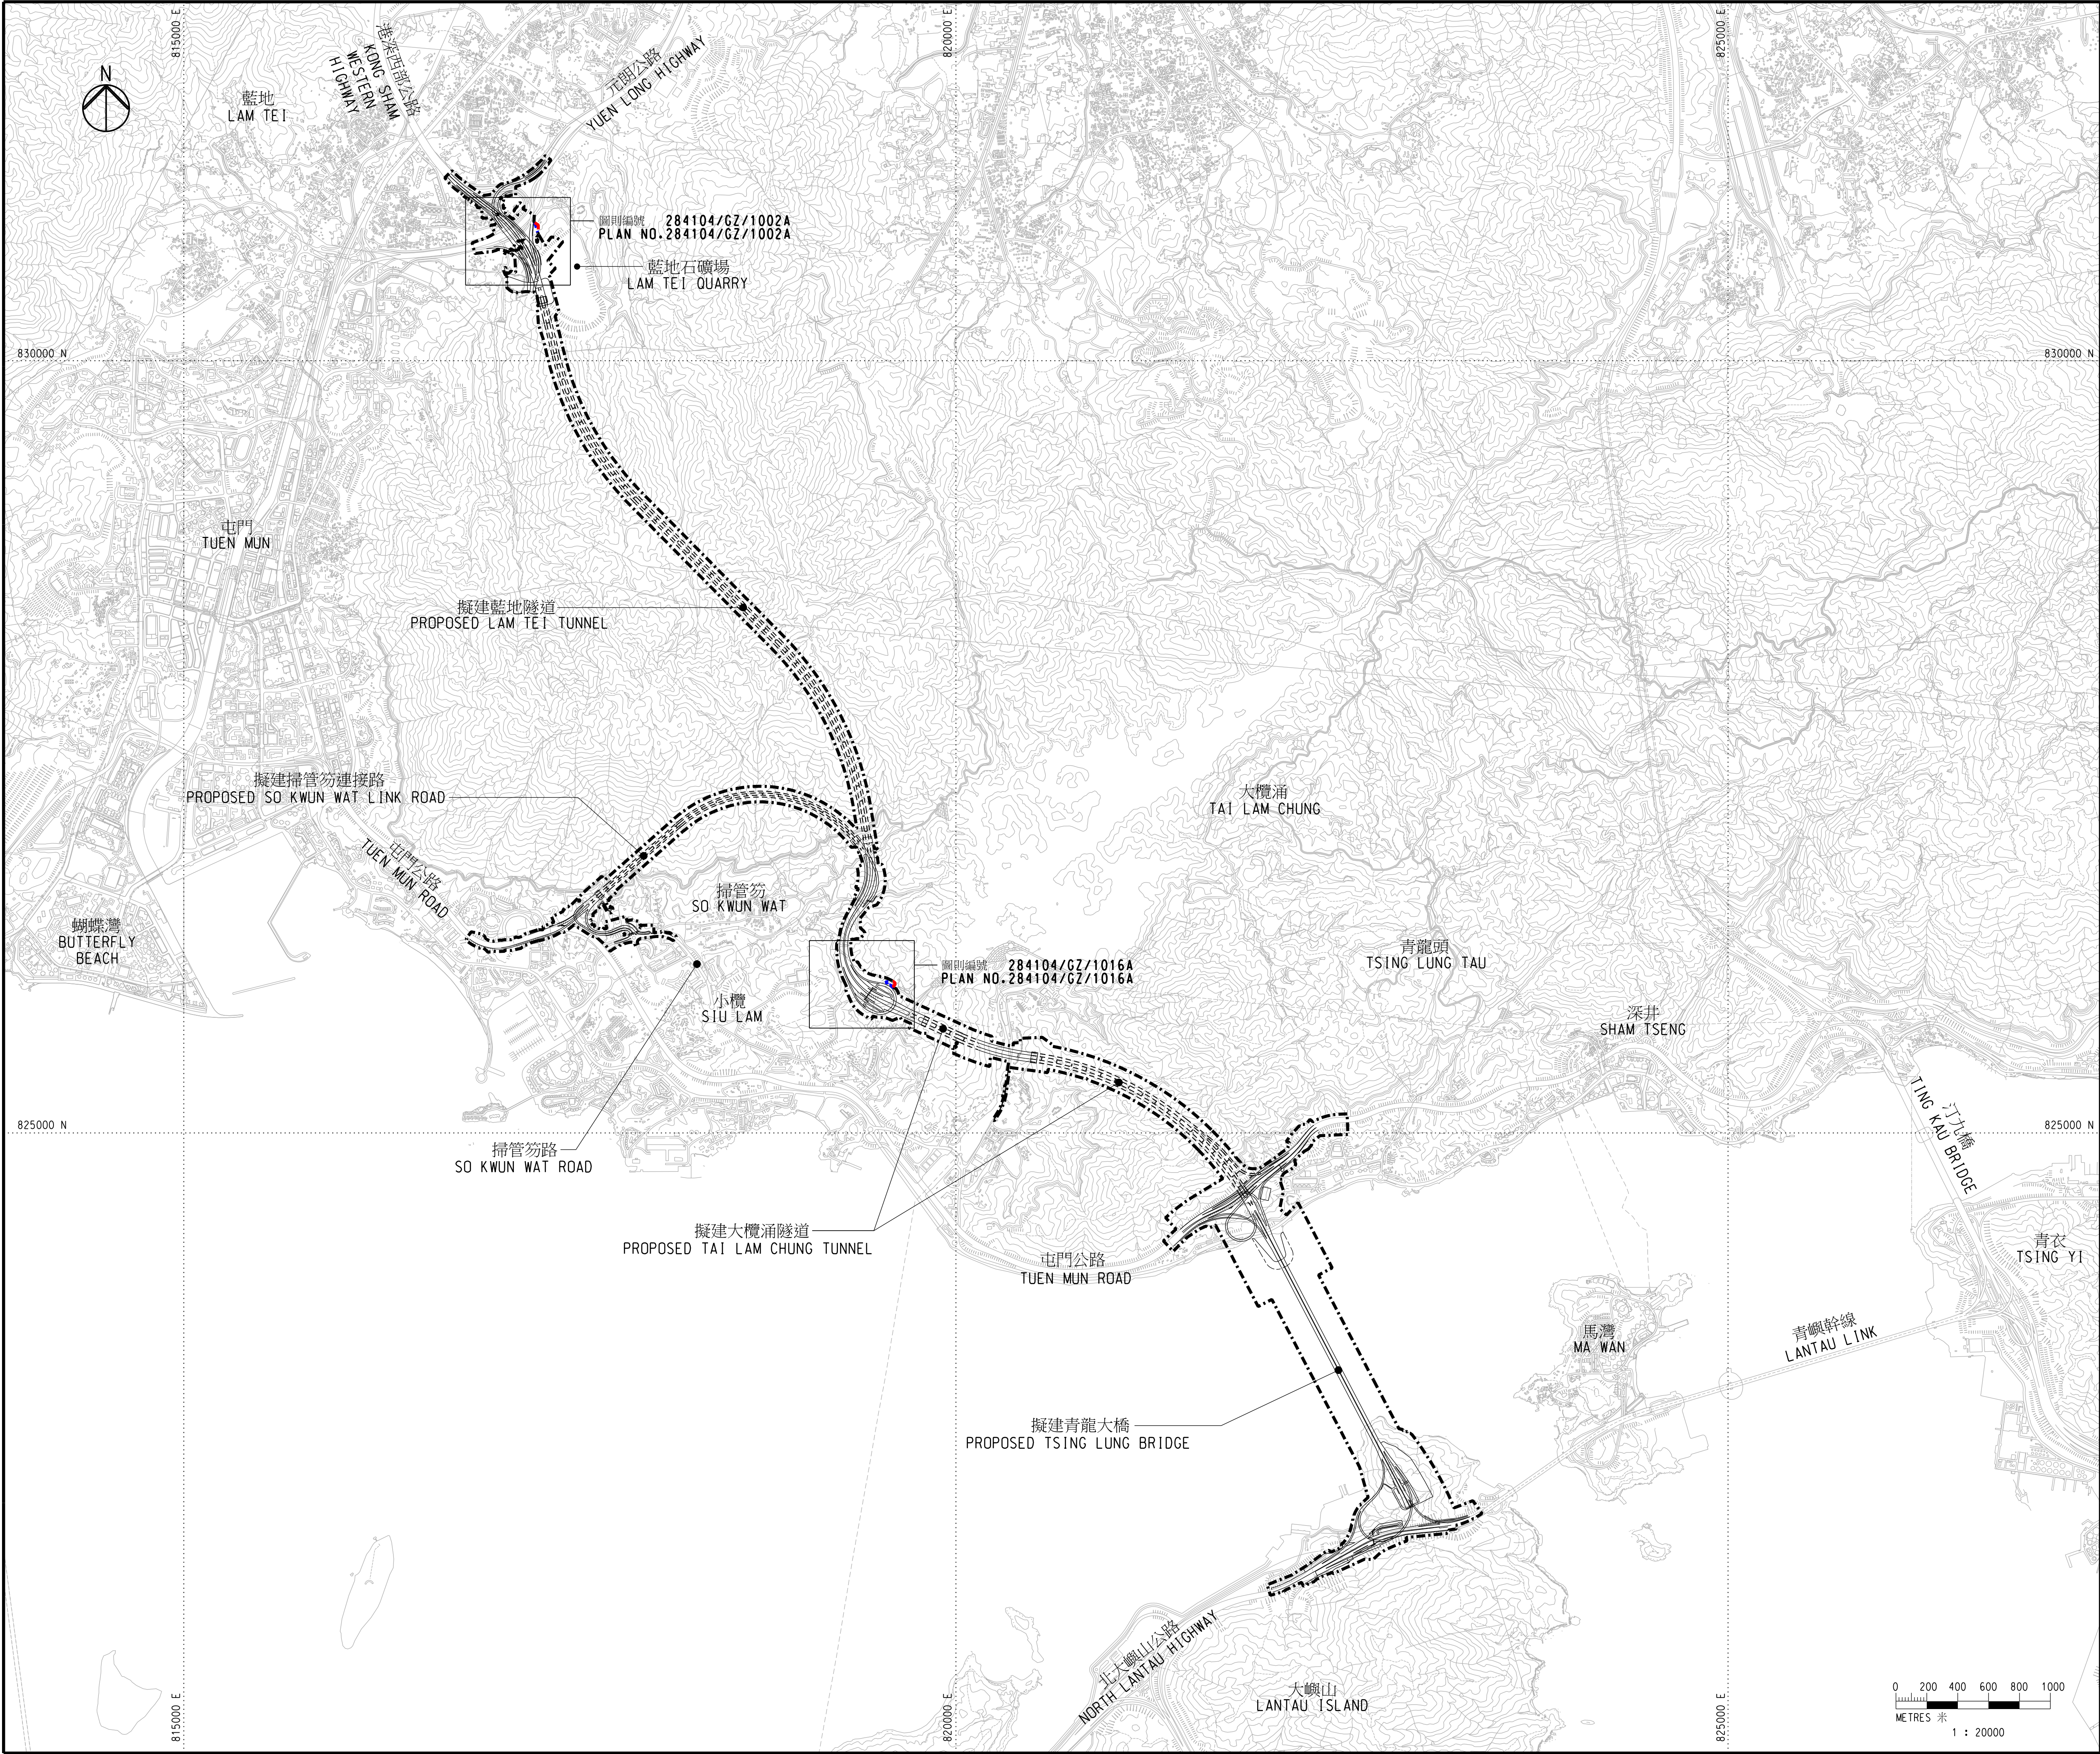

註釋:

NOTES:

- 除另有指明外，所有量度以米為單位。
ALL DIMENSIONS ARE IN METRES UNLESS OTHERWISE SPECIFIED.
- 所有水平均為約數，以米為單位，並在香港主水平基準以上。
ALL LEVELS ARE APPROXIMATE VALUES AND IN METRES ABOVE HONG KONG PRINCIPAL DATUM.
- 如有需要，施工區界限內部份現有地面行車道、高架行車道、行人路/樓梯、美化市容地帶、地面中央分隔帶/安全島及高架中央分隔帶/安全島或會分階段暫時封閉。
SECTIONS OF THE EXISTING AT-GRADE CARRIAGEWAYS, ELEVATED CARRIAGEWAYS, FOOTPATHS/STAIRCASES, AMENITY AREAS, AT-GRADE CENTRAL RESERVES/REFUGE ISLANDS AND ELEVATED CENTRAL RESERVES/REFUGE ISLANDS WITHIN THE LIMIT OF WORKS AREA MAY BE TEMPORARILY CLOSED IN PHASES AS AND WHEN REQUIRED.
- 如有需要，斜坡穩固工程或會在施工區界限內進行。
SLOPE STABILIZATION WORKS MAY BE CARRIED OUT WITHIN THE LIMIT OF WORKS AREA AS AND WHEN REQUIRED.
- 如有需要，施工區界限內之現有海堤或會實施臨時保護及預防工作。
TEMPORARY PROTECTIVE AND PRECAUTIONARY WORKS MAY BE CARRIED OUT ON EXISTING SEAWALL WITHIN THE LIMIT OF WORKS AREA AS AND WHEN REQUIRED.

圖例:

LEGEND:

原有部份 ORIGINAL

- 原施工區界限 ORIGINAL LIMIT OF WORKS AREA

修改部份 MODIFICATION

- 原施工區界限將予刪除 ORIGINAL LIMIT OF WORKS AREA TO BE DELETED
- 修改後之施工區界限 MODIFIED LIMIT OF WORKS AREA

Authorized by the Chief Executive in Council

經行政長官會同行政會議授權進行


工程名稱 PROJECT TITLE	
工務計劃項目第6884TH號 十一號幹線（元朗至北大嶼山段）	
PWP ITEM NO. 6884TH ROUTE 11 (SECTION BETWEEN YUEN LONG AND NORTH LANTAU)	
圖則名稱 PLAN TITLE	
修改圖則 MODIFICATION PLAN	
索引圖 KEY PLAN	
圖則編號 PLAN NO.	比例 SCALE
284104/GZ/1000A	1:20000 @ A1
版權所有 COPYRIGHT RESERVED	
辦事處 OFFICE	
主要工程管理處 MAJOR WORKS PROJECT MANAGEMENT OFFICE	

路政署
HIGHWAYS DEPARTMENT

0 200 400 600 800 1000

METRES 米

1 : 20000

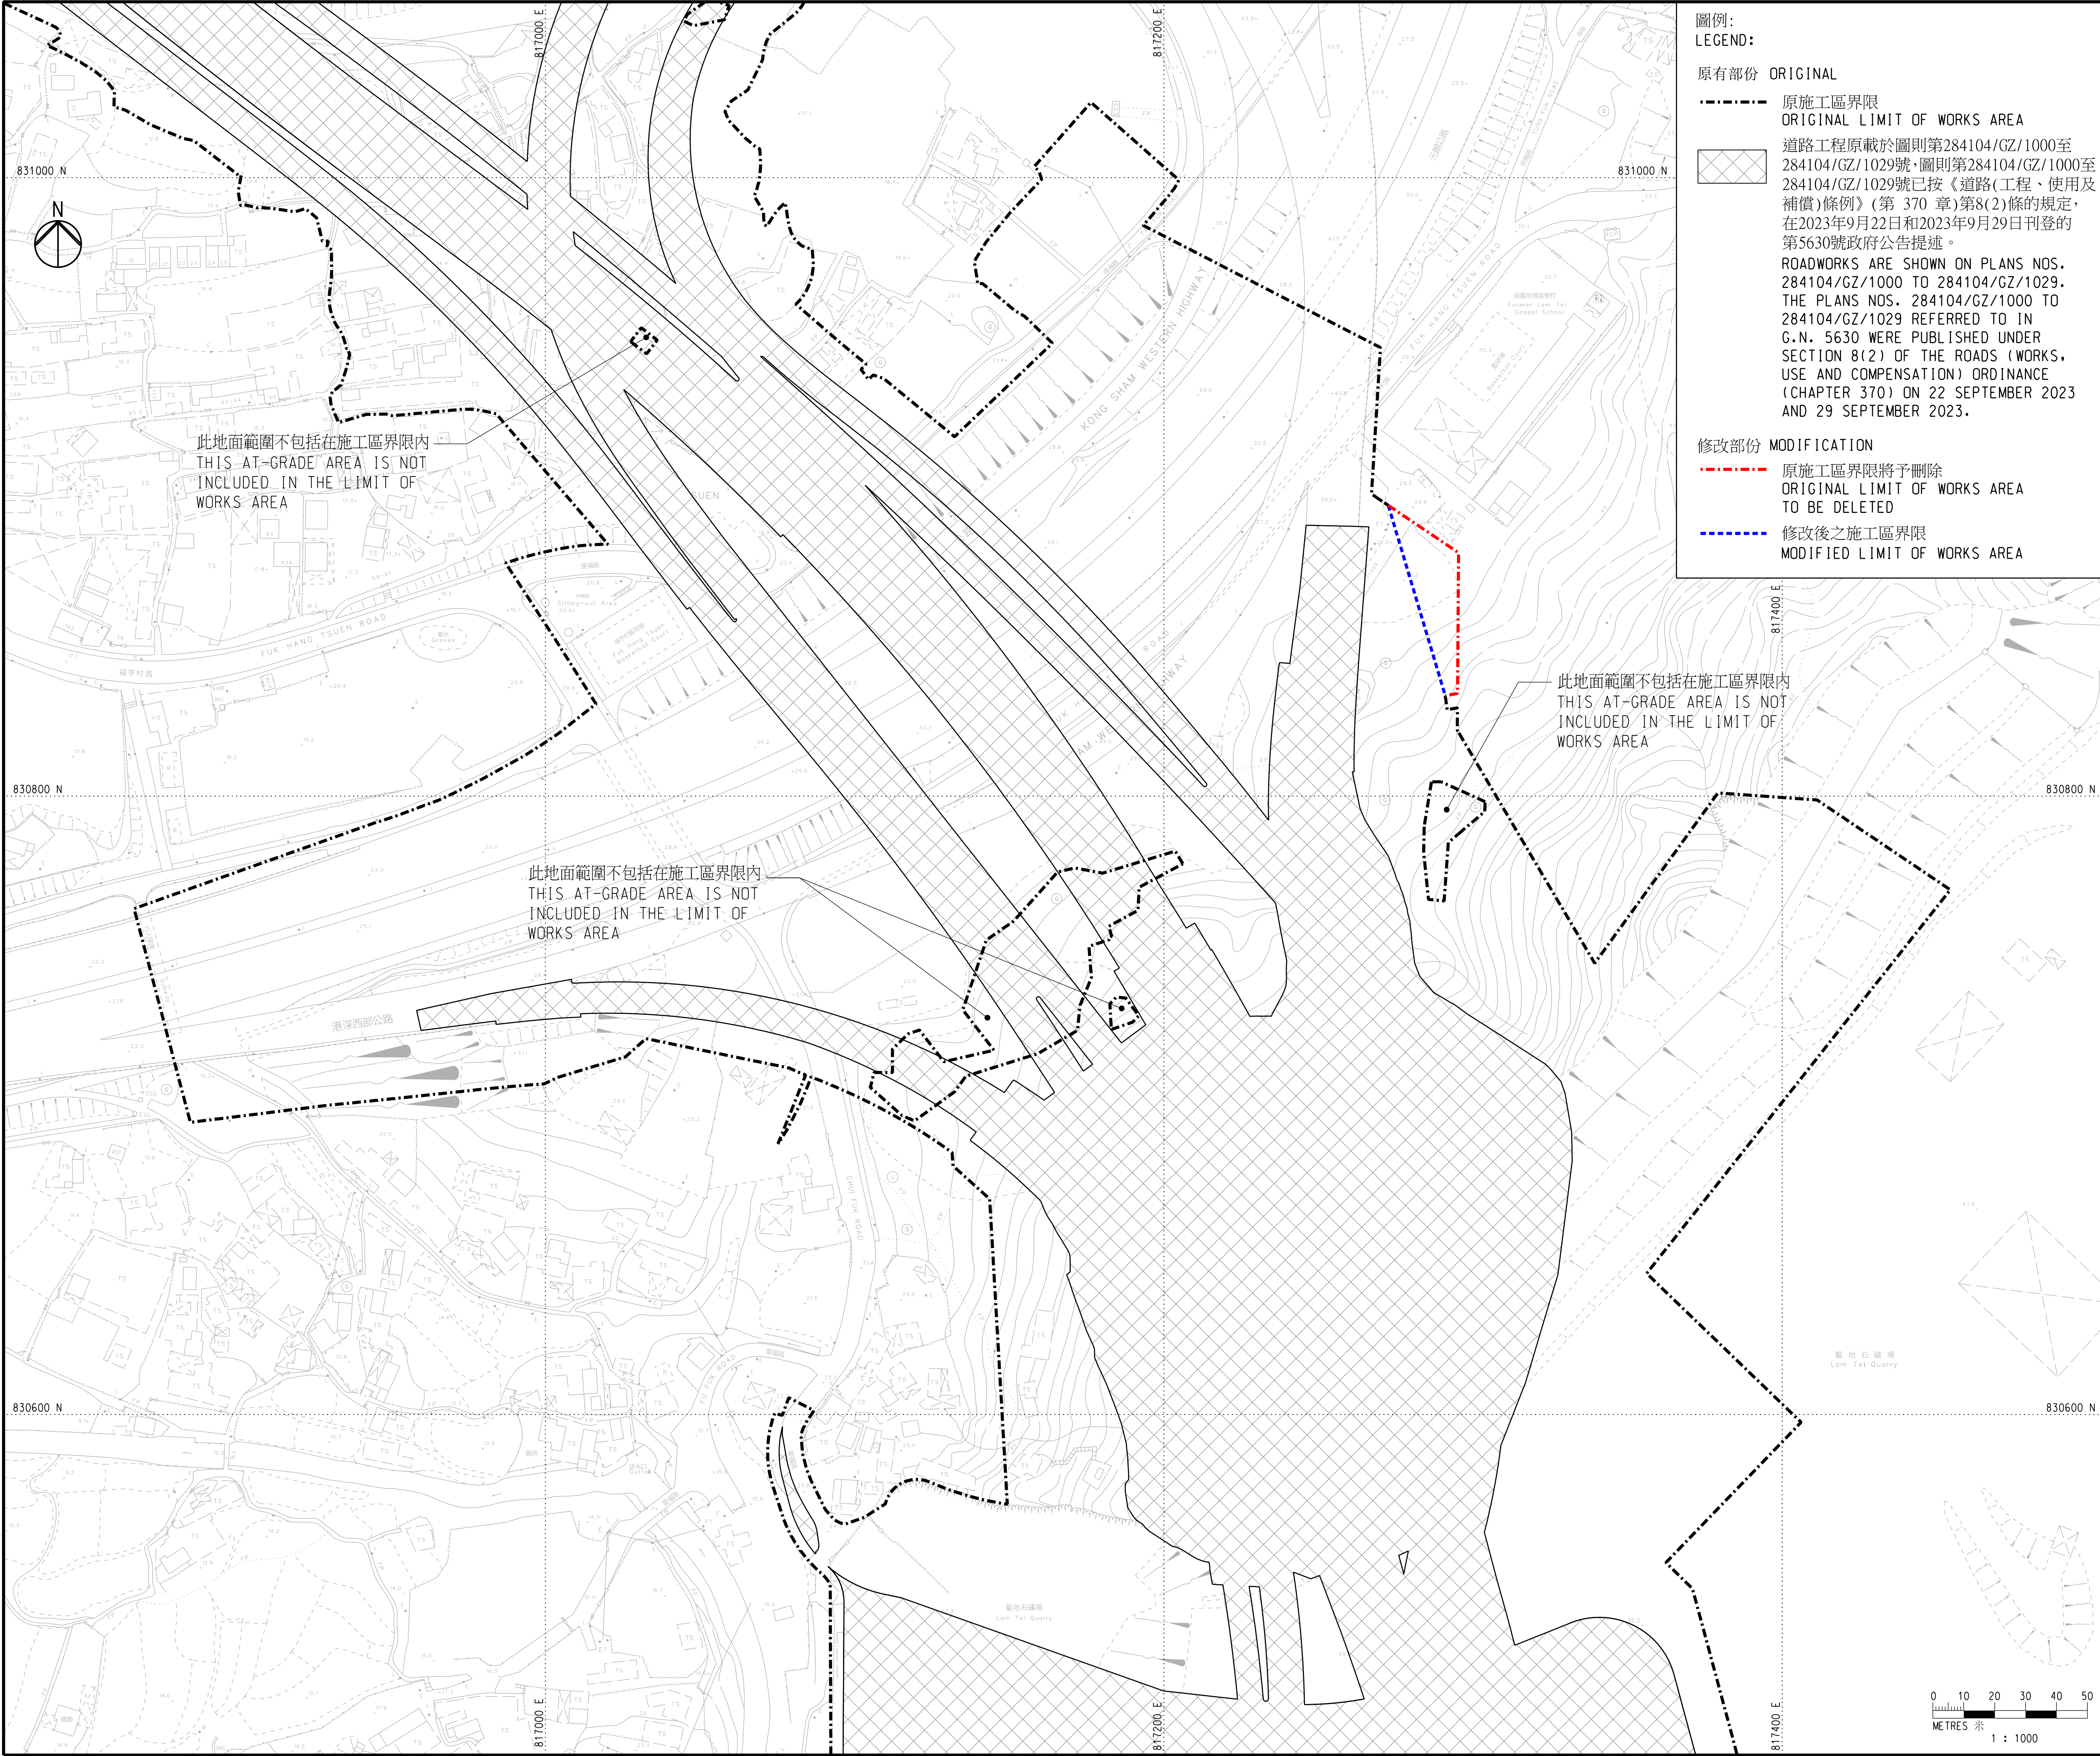

圖例:
LEGEND:

原有部份 ORIGINAL

----- 原施工區界限
ORIGINAL LIMIT OF WORKS AREA

道路工程原載於圖則第284104/GZ/1000至284104/GZ/1029號,圖則第284104/GZ/1000至284104/GZ/1029號已按《道路(工程、使用及補償)條例》(第 370 章)第8(2)條的規定,在2023年9月22日和2023年9月29日刊登的第5630號政府公告提述。

ROADWORKS ARE SHOWN ON PLANS NOS. 284104/GZ/1000 TO 284104/GZ/1029. THE PLANS NOS. 284104/GZ/1000 TO 284104/GZ/1029 REFERRED TO IN G.N. 5630 WERE PUBLISHED UNDER SECTION 8(2) OF THE ROADS (WORKS, USE AND COMPENSATION) ORDINANCE (CHAPTER 370) ON 22 SEPTEMBER 2023 AND 29 SEPTEMBER 2023.

修改部份 MODIFICATION

----- 原施工區界限將予刪除
ORIGINAL LIMIT OF WORKS AREA TO BE DELETED

----- 修改後之施工區界限
MODIFIED LIMIT OF WORKS AREA


註釋:
NOTES:

- 除另有指明外,所有量度以米為單位。
ALL DIMENSIONS ARE IN METRES UNLESS OTHERWISE SPECIFIED.
- 所有水平均為約數,以米為單位,並在香港主水平基準以上。
ALL LEVELS ARE APPROXIMATE VALUES AND IN METRES ABOVE HONG KONG PRINCIPAL DATUM.
- 如有需要,施工區界限內部份現有地面行車道、高架行車道、行人路/樓梯、美化市容地帶、地面中央分隔帶/安全島及高架中央分隔帶/安全島或會分階段暫時封閉。
SECTIONS OF THE EXISTING AT-GRADE CARRIAGEWAYS, ELEVATED CARRIAGEWAYS, FOOTPATHS/STAIRCASES, AMENITY AREAS, AT-GRADE CENTRAL RESERVES/REFUGE ISLANDS AND ELEVATED CENTRAL RESERVES/REFUGE ISLANDS WITHIN THE LIMIT OF WORKS AREA MAY BE TEMPORARILY CLOSED IN PHASES AS AND WHEN REQUIRED.
- 如有需要,斜坡穩固工程或會在施工區界限內進行。
SLOPE STABILIZATION WORKS MAY BE CARRIED OUT WITHIN THE LIMIT OF WORKS AREA AS AND WHEN REQUIRED.
- 如有需要,施工區界限內之現有海堤或會實施臨時保護及預防工作。
TEMPORARY PROTECTIVE AND PRECAUTIONARY WORKS MAY BE CARRIED OUT ON EXISTING SEAWALL WITHIN THE LIMIT OF WORKS AREA AS AND WHEN REQUIRED.
- 圖例載於圖則第284104/GZ/LB號。
LEGEND IS SHOWN ON PLAN NO. 284104/GZ/LEG.

Authorized by the Chief Executive in Council

經行政長官會同行政會議授權進行

工程名稱 PROJECT TITLE	
工務計劃項目第6884TH號 十一號幹線(元朗至北大嶼山段)	
PWP ITEM NO. 6884TH ROUTE 11 (SECTION BETWEEN YUEN LONG AND NORTH LANTAU)	
圖則名稱 PLAN TITLE	
修改圖則 MODIFICATION PLAN	
二張之第一張 SHEET 1 OF 2	
圖則編號 PLAN NO.	比例 SCALE
284104/GZ/1002A	1:1000 @ A1
版權所有 COPYRIGHT RESERVED	
辦事處 OFFICE	
主要工程管理處 MAJOR WORKS PROJECT MANAGEMENT OFFICE	
 路政署 HIGHWAYS DEPARTMENT	

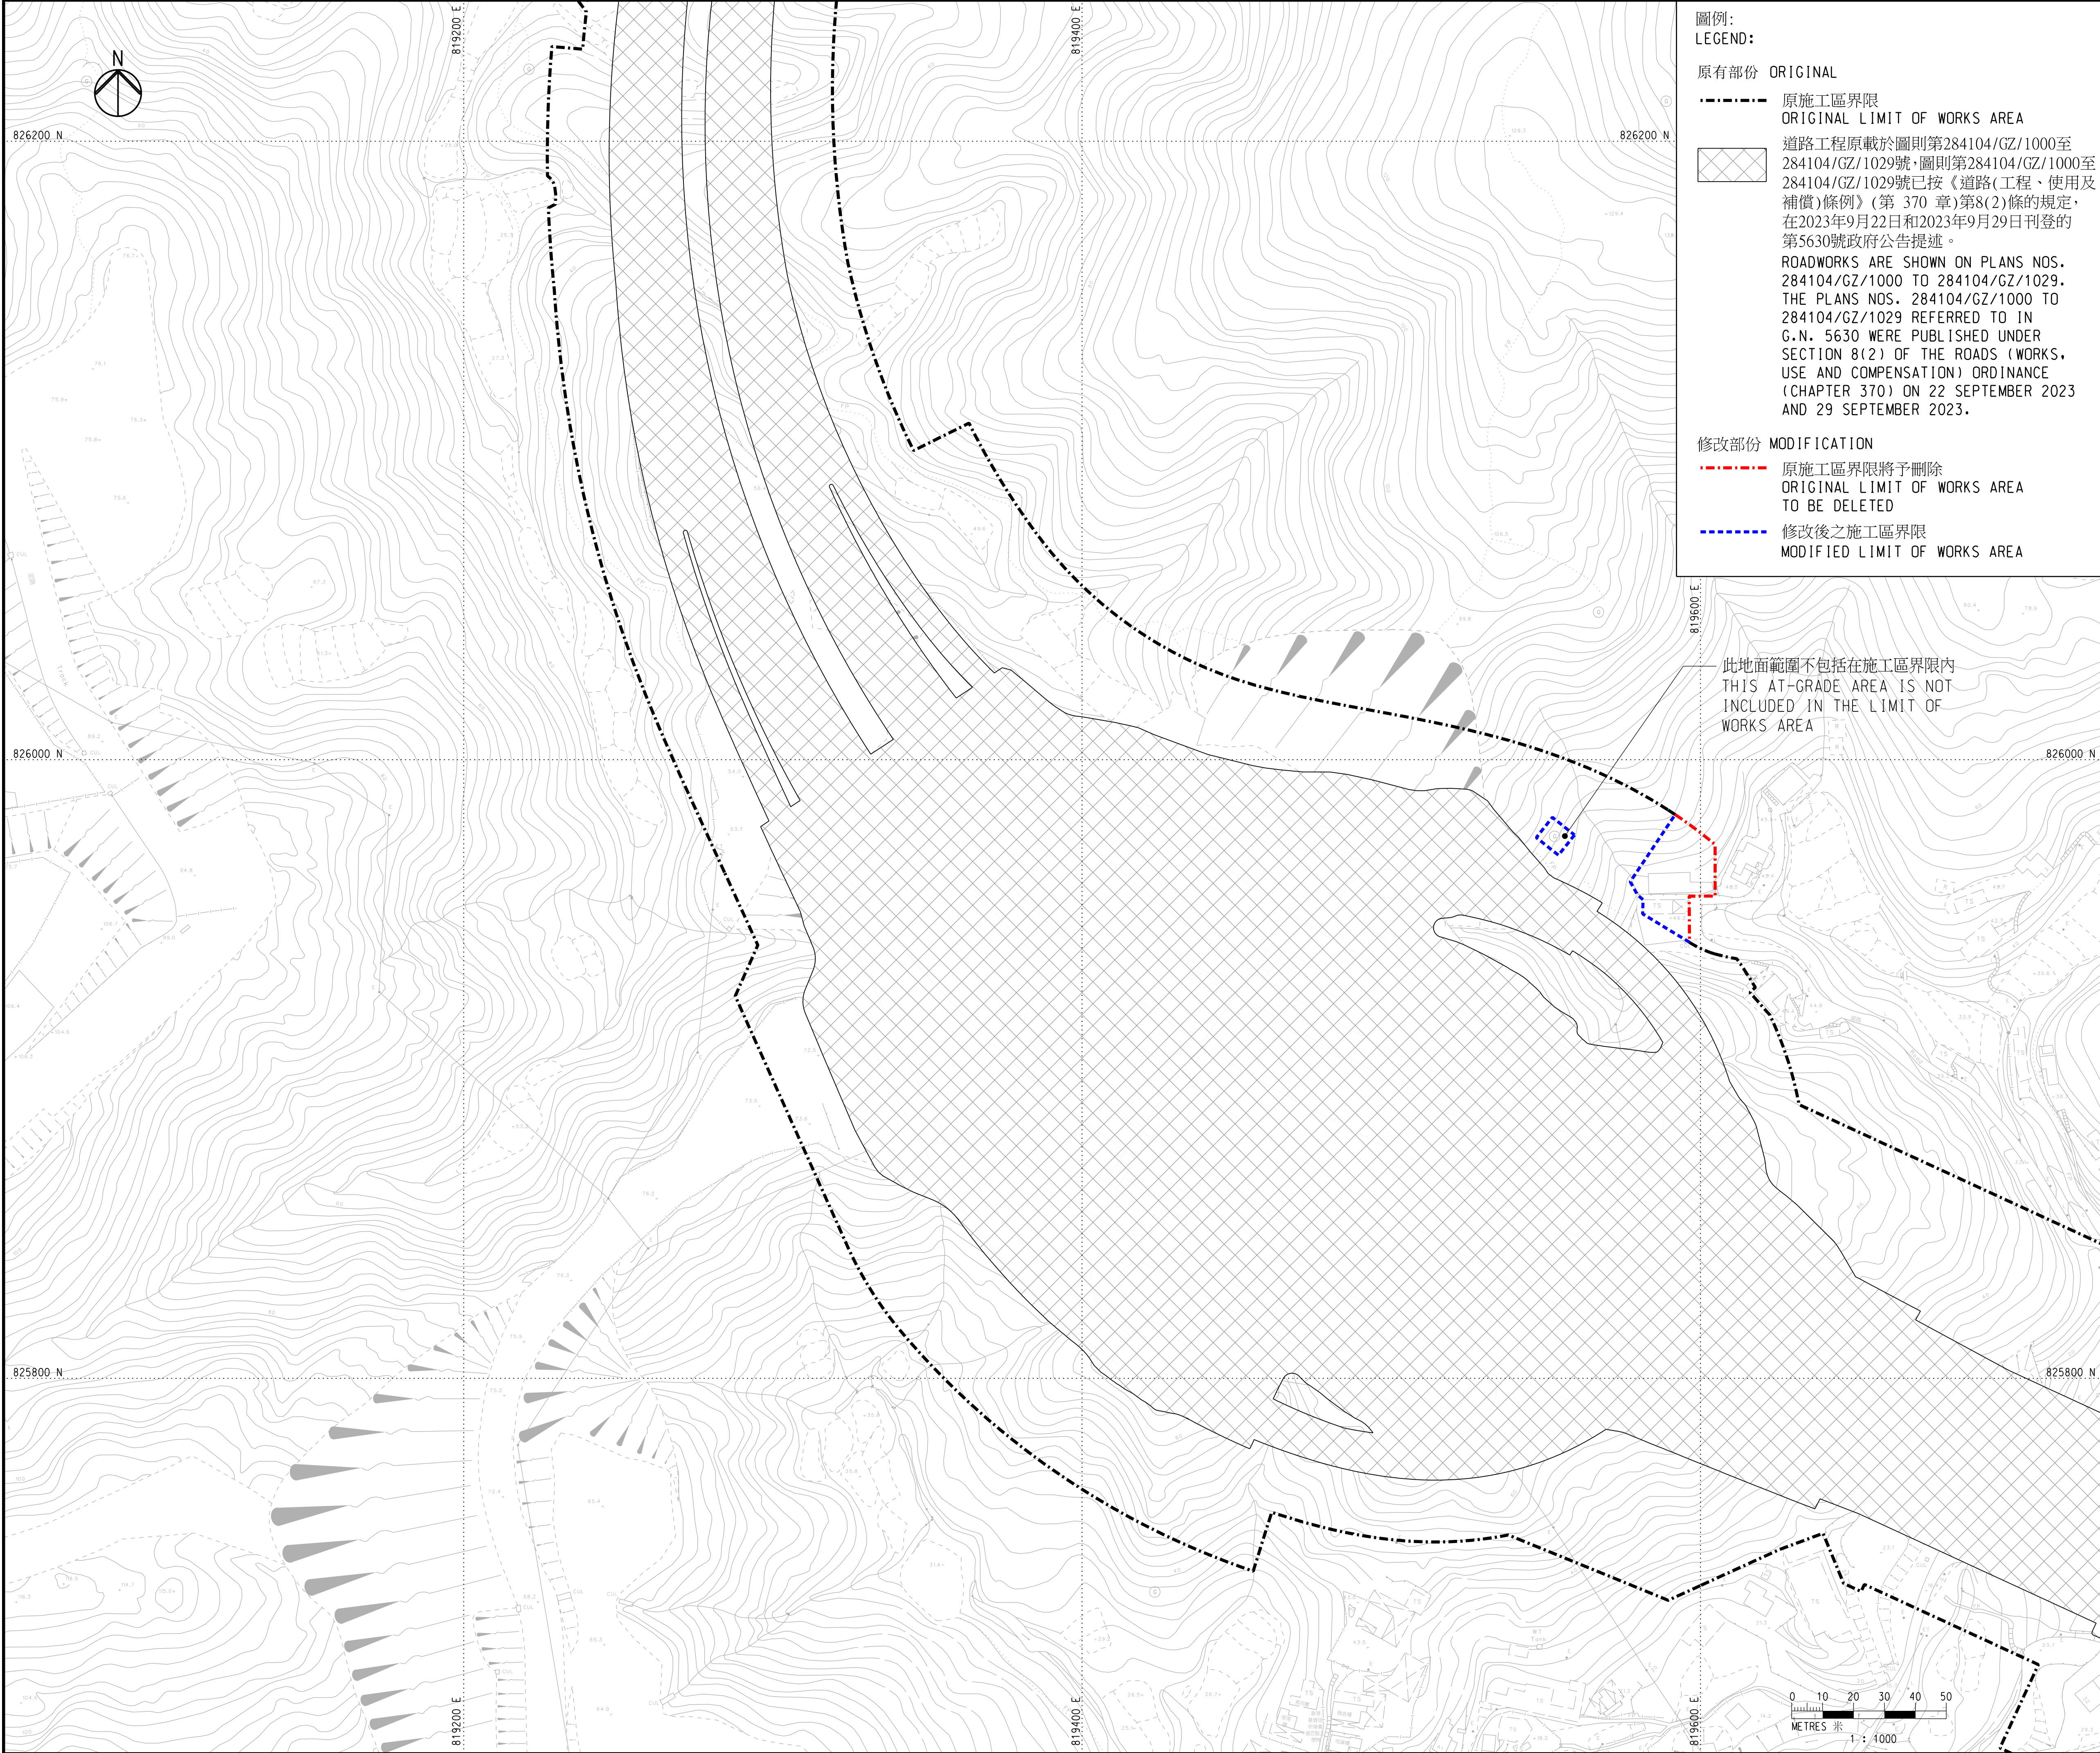

圖例:
LEGEND:

原有部份 ORIGINAL
原施工區界限
ORIGINAL LIMIT OF WORKS AREA

道路工程原載於圖則第284104/GZ/1000至284104/GZ/1029號,圖則第284104/GZ/1000至284104/GZ/1029號已按《道路(工程、使用及補償)條例》(第 370 章)第8(2)條的規定,在2023年9月22日和2023年9月29日刊登的第5630號政府公告提述。
ROADWORKS ARE SHOWN ON PLANS NOS. 284104/GZ/1000 TO 284104/GZ/1029. THE PLANS NOS. 284104/GZ/1000 TO 284104/GZ/1029 REFERRED TO IN G.N. 5630 WERE PUBLISHED UNDER SECTION 8(2) OF THE ROADS (WORKS, USE AND COMPENSATION) ORDINANCE (CHAPTER 370) ON 22 SEPTEMBER 2023 AND 29 SEPTEMBER 2023.

修改部份 MODIFICATION
原施工區界限將予刪除
ORIGINAL LIMIT OF WORKS AREA TO BE DELETED

修改後之施工區界限
MODIFIED LIMIT OF WORKS AREA

註釋:
NOTES:

- 除另有指明外,所有量度以米為單位。
ALL DIMENSIONS ARE IN METRES UNLESS OTHERWISE SPECIFIED.
- 所有水平均為約數,以米為單位,並在香港主水平基準以上。
ALL LEVELS ARE APPROXIMATE VALUES AND IN METRES ABOVE HONG KONG PRINCIPAL DATUM.
- 如有需要,施工區界限內部份現有地面行車道、高架行車道、行人路/樓梯、美化市容地帶、地面中央分隔帶/安全島及高架中央分隔帶/安全島或會分階段暫時封閉。
SECTIONS OF THE EXISTING AT-GRADE CARRIAGEWAYS, ELEVATED CARRIAGEWAYS, FOOTPATHS/STAIRCASES, AMENITY AREAS, AT-GRADE CENTRAL RESERVES/REFUGE ISLANDS AND ELEVATED CENTRAL RESERVES/REFUGE ISLANDS WITHIN THE LIMIT OF WORKS AREA MAY BE TEMPORARILY CLOSED IN PHASES AS AND WHEN REQUIRED.
- 如有需要,斜坡穩固工程或會在施工區界限內進行。
SLOPE STABILIZATION WORKS MAY BE CARRIED OUT WITHIN THE LIMIT OF WORKS AREA AS AND WHEN REQUIRED.
- 如有需要,施工區界限內之現有海堤或會實施臨時保護及預防工作。
TEMPORARY PROTECTIVE AND PRECAUTIONARY WORKS MAY BE CARRIED OUT ON EXISTING SEAWALL WITHIN THE LIMIT OF WORKS AREA AS AND WHEN REQUIRED.
- 圖例載於圖則第284104/GZ/LEG號。
LEGEND IS SHOWN ON PLAN NO. 284104/GZ/LEG.

Authorized by the Chief Executive in Council

經行政長官會同行政會議授權進行

工程名稱 PROJECT TITLE 工務計劃項目第6884TH號 十一號幹線(元朗至北大嶼山段) PWP ITEM NO. 6884TH ROUTE 11 (SECTION BETWEEN YUEN LONG AND NORTH LANTAU)	
圖則名稱 PLAN TITLE 修改圖則 MODIFICATION PLAN	
圖則編號 PLAN NO. 284104/GZ/1016A	二張之第二張 SHEET 2 OF 2 比例 SCALE 1:1000 @ A1
版權所有 COPYRIGHT RESERVED	
辦事處 OFFICE 主要工程管理處 MAJOR WORKS PROJECT MANAGEMENT OFFICE	
路政署 HIGHWAYS DEPARTMENT	